



Prime
56' x 14'

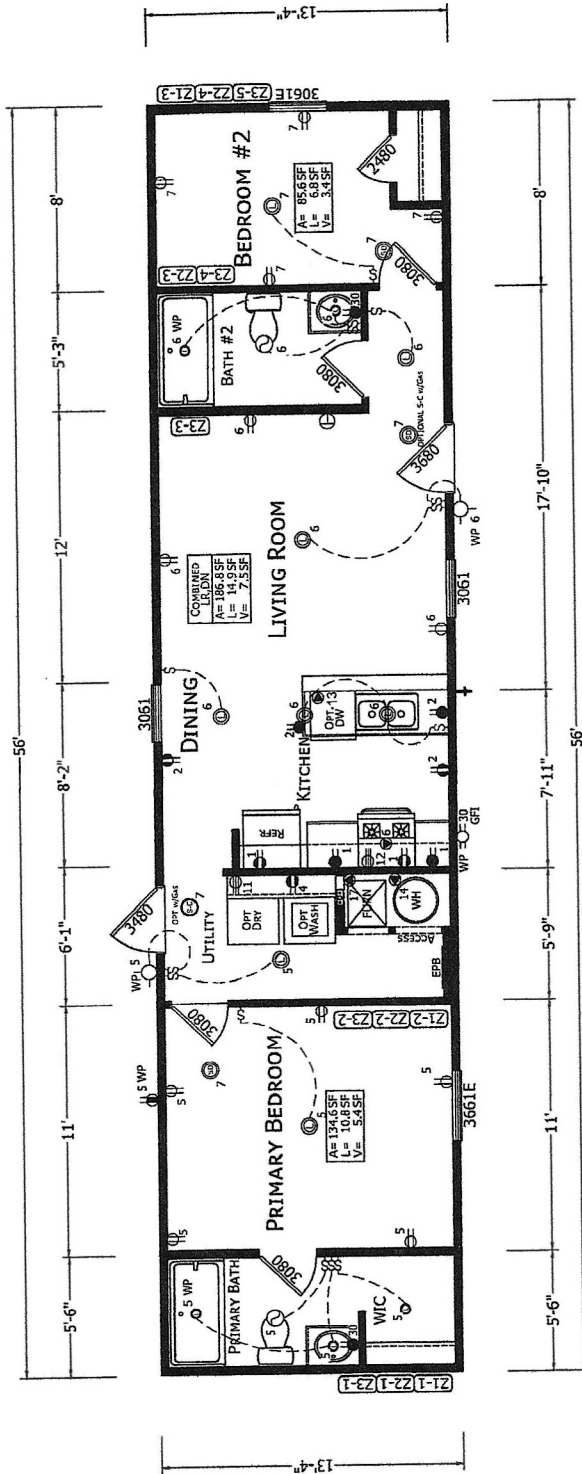

CHAMPION HOME BUILDERS <small>285 W. BIG SAKER BLVD. SUITE 1000 TROY, MI 48064 PHONE: 313.414.8200</small>	 #25 Confirms to HUD MHCSS 3/1/23	PROJECT: 1456H22P01 56'-0" x 13'-4" 2 BD 2 BT	SHEET: AE-101
		MODIFICATIONS:	TITLE: FLOOR PLAN ELECTRICAL PLAN
		DRAWN BY: SAGE ELLISON DATE: 02-27-23 SCALE: 3/32" = 1'-0"	FILENAME: 1456H22P01 <small>PROPRIETARY AND CONFIDENTIAL 56'-0" x 13'-4" PROPRIETARY AND CONFIDENTIAL MATERIALS OF CHAMPION COPYRIGHT © 1999-2023 BY CHAMPION</small>